


Transco

1100 Century Way,
Thorpe Park,
Leeds
LS15 8TU

Telephone No: 0113 290 8573
Fax No: 0113 290 8078

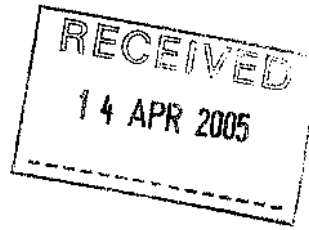

Gillespies
Minton Chambers
12 Heatons Court
Leeds
LS1 4LJ

Our Ref: 6434
Your Ref: M3913/C3

13th April 2005

For The Attention Of Adam Graytrix.

Dear Sir,

GAS MAIN DIVERSION AT HIGH ROW. DARLINGTON.

Further to your letter dated 16th February 2005 in respect of the above, please find enclosed a copy of our 1:1250 scale plan indicating the necessary diversion of our low pressure gas main in order to accommodate your scheme.

The budget indicative estimate of the diversion of our existing 300mm Ductile Iron Low Pressure with 355mm PE mains to allow your proposed development, is a estimated rechargeable cost of £22,105 Inc VAT.

This estimate should only be regarded as a guide, which has been prepared with all the information, which it was reasonably possible to obtain beforehand.


This estimate doesn't constitute an official quotation, which can be accepted. When an official quotation has been quoted & accepted there is where possible a minimum of 14 weeks prior to our commencing work on site.

Please do not hesitate to contact Garry Judge on telephone number 0113 290 8573 should you require any further assistance in this matter.

Yours faithfully,

A handwritten signature in black ink, appearing to be "D Carter".

D Carter
Network Support Manager

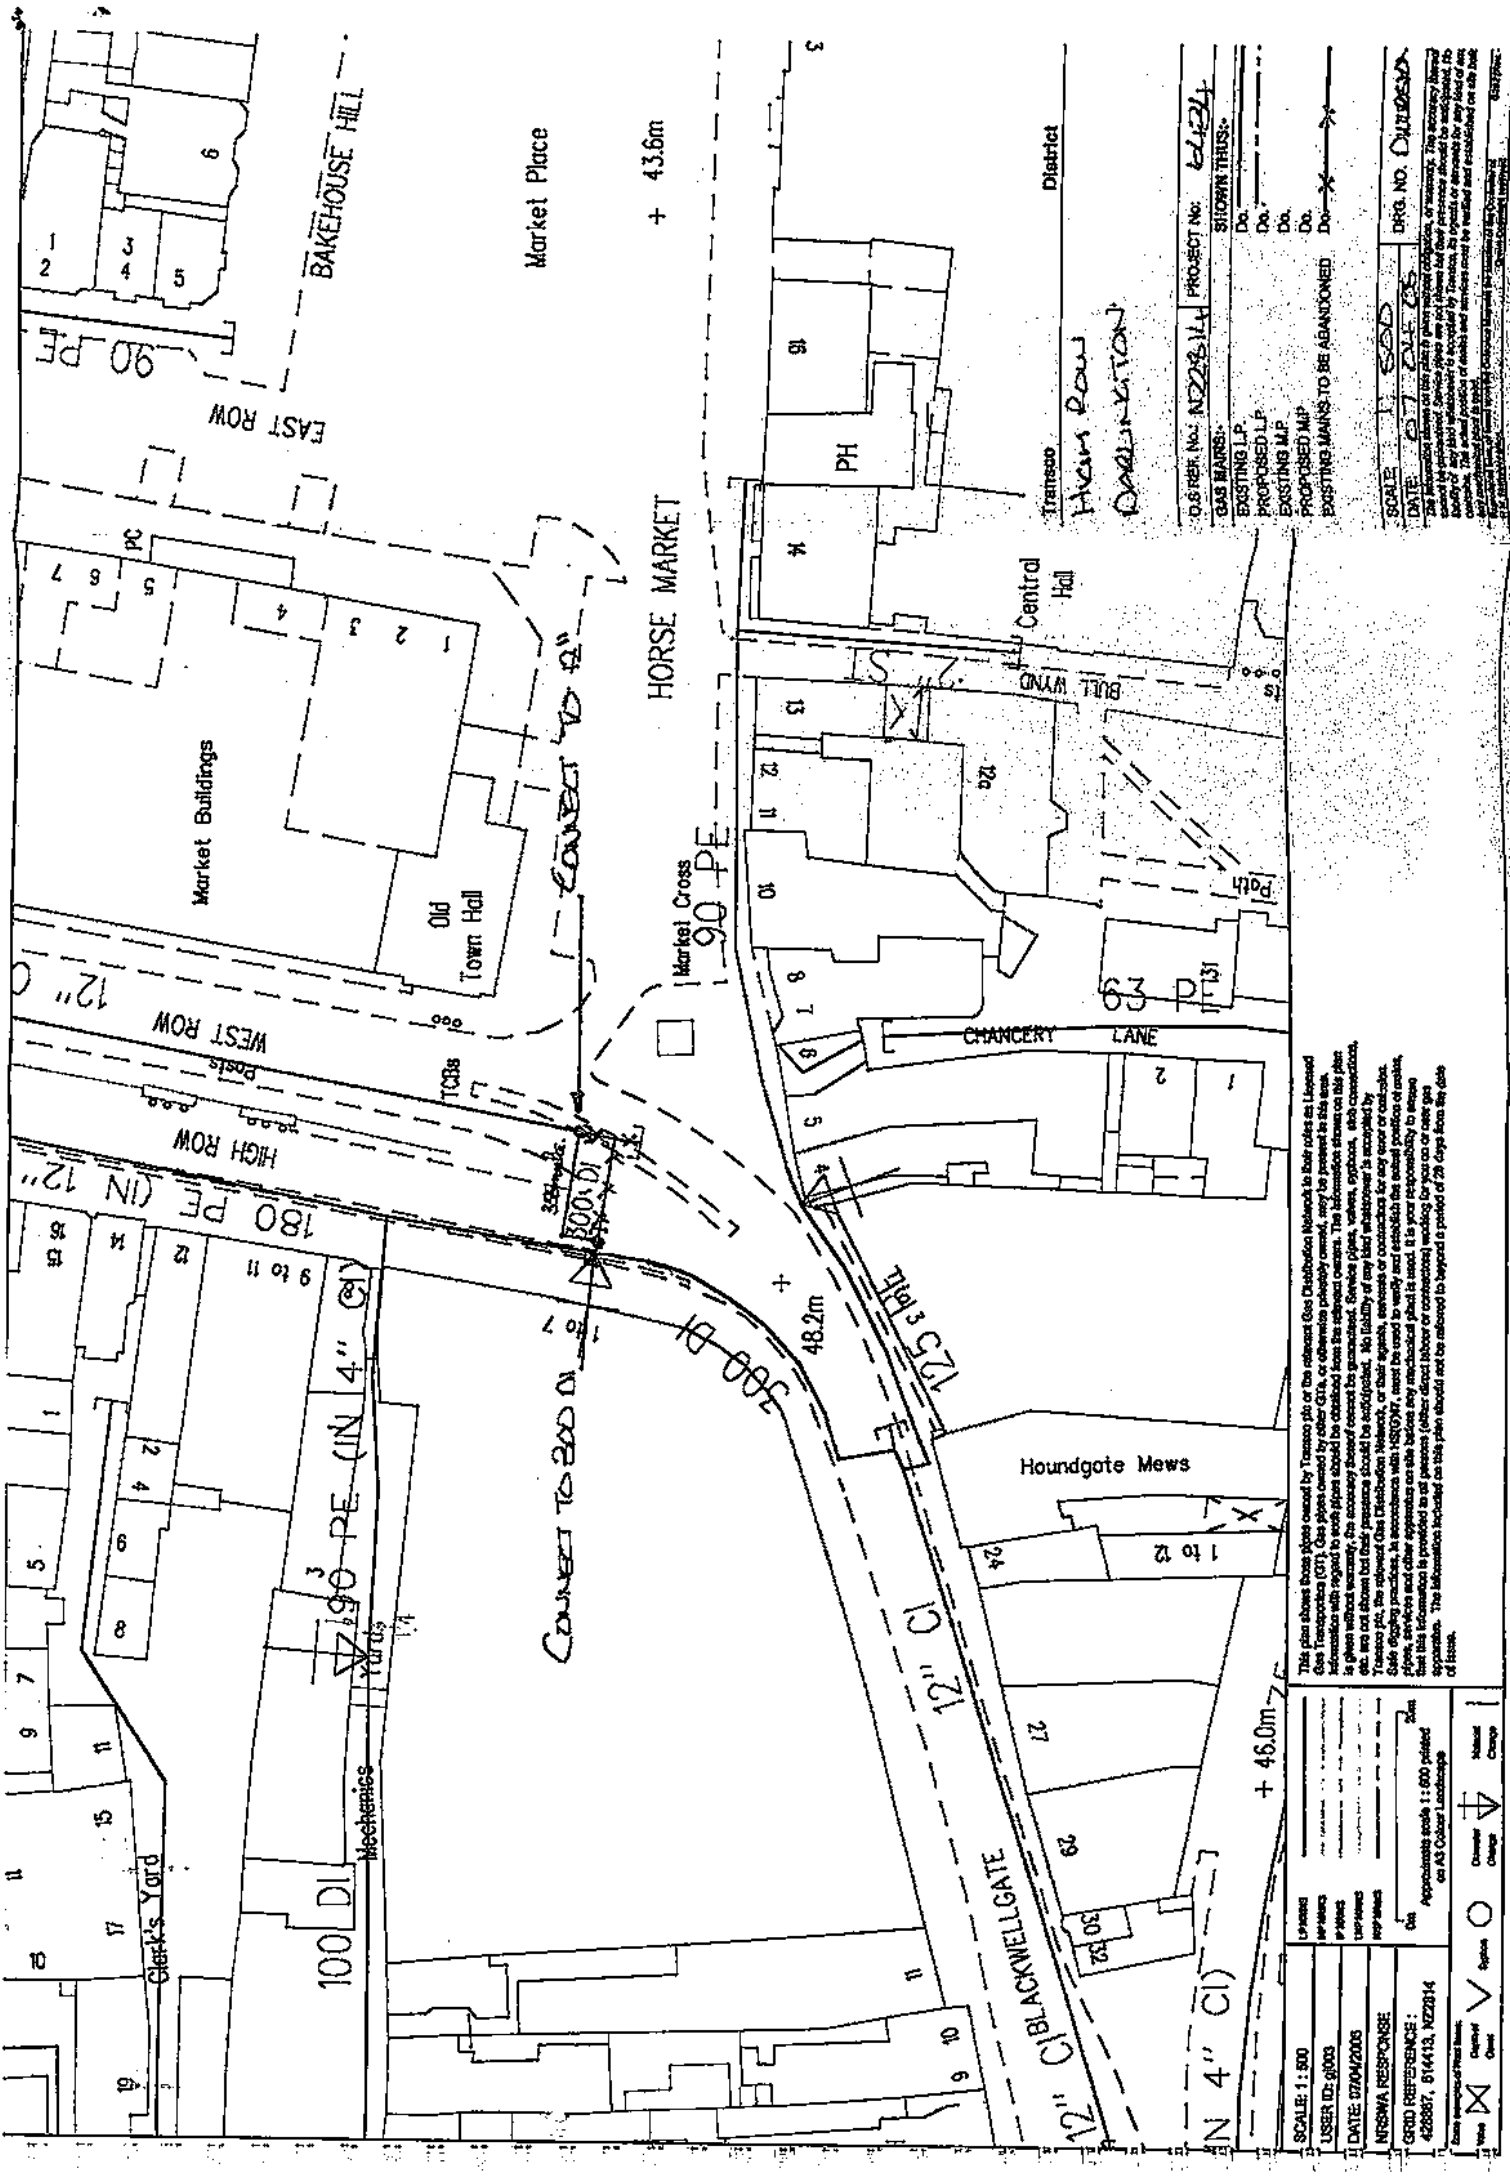

O.S. REF. NO.: NZ2314 PROJECT NO.: 6124
 GAS MARRS. SHOWN THIS:-
 EXISTING L.P. Do. Do.
 PROPOSED L.P. Do. Do.
 EXISTING M.P. Do. Do.
 PROPOSED M.P. Do. Do.
 EXISTING MARKS TO BE ABANDONED Do. Do.

SCALE: 1:500
 DATE: 07/05/05
 DRG. NO.: D124/05

This plan shows those pipes owned by Transco plc or the relevant Gas Distribution Network to their role as Licensed Gas Transporter (GT). Gas pipes owned by other GTs, or otherwise privately owned, may be present in this area. Information with regard to such pipes should be obtained from the relevant owners. The information shown on this plan is given without warranty, the necessary consent being guaranteed. Services pipes, sewers, overhead, and other connections, do not show on this plan. The necessary consent should be sought. No liability of any kind whatsoever is accepted by Transco plc, the relevant Gas Distribution Network, or their agents, servants or contractors for any error or omission. Self-regulating practices, in accordance with WSG047, must be used to verify and establish the correct position of cables. Cable markers and other apparatus on site before any mechanical plant is used. It is your responsibility to arrange appropriate protection for all persons (other than those of your own company) working for you or your gas suppliers. The information included on this plan should not be relied upon beyond a period of 28 days from the date of issue.

SCALE: 1:500	APPROXIMATE SCALE: 1:500 plotted on A3 Colour Landscape
USER ID: 6003	
DATE: 07/04/2005	
INRSWA RESPONSE	
GRID REFERENCE: 428867, 814413, NZ2314	

Scale: 1:500
 User ID: 6003
 Date: 07/04/2005
 InRSWA Response
 Grid Reference: 428867, 814413, NZ2314

1. View 2. Check 3. Check 4. Check 5. Check 6. Check 7. Check 8. Check 9. Check 10. Check 11. Check 12. Check 13. Check 14. Check 15. Check 16. Check 17. Check 18. Check 19. Check 20. Check 21. Check 22. Check 23. Check 24. Check 25. Check 26. Check 27. Check 28. Check 29. Check 30. Check 31. Check 32. Check 33. Check 34. Check 35. Check 36. Check 37. Check 38. Check 39. Check 40. Check 41. Check 42. Check 43. Check 44. Check 45. Check 46. Check 47. Check 48. Check 49. Check 50. Check 51. Check 52. Check 53. Check 54. Check 55. Check 56. Check 57. Check 58. Check 59. Check 60. Check 61. Check 62. Check 63. Check 64. Check 65. Check 66. Check 67. Check 68. Check 69. Check 70. Check 71. Check 72. Check 73. Check 74. Check 75. Check 76. Check 77. Check 78. Check 79. Check 80. Check 81. Check 82. Check 83. Check 84. Check 85. Check 86. Check 87. Check 88. Check 89. Check 90. Check 91. Check 92. Check 93. Check 94. Check 95. Check 96. Check 97. Check 98. Check 99. Check 100. Check 101. Check 102. Check 103. Check 104. Check 105. Check 106. Check 107. Check 108. Check 109. Check 110. Check 111. Check 112. Check 113. Check 114. Check 115. Check 116. Check 117. Check 118. Check 119. Check 120. Check 121. Check 122. Check 123. Check 124. Check 125. Check 126. Check 127. Check 128. Check 129. Check 130. Check 131. Check 132. Check 133. Check 134. Check 135. Check 136. Check 137. Check 138. Check 139. Check 140. Check 141. Check 142. Check 143. Check 144. Check 145. Check 146. Check 147. Check 148. Check 149. Check 150. Check 151. Check 152. Check 153. Check 154. Check 155. Check 156. Check 157. Check 158. Check 159. Check 160. Check 161. Check 162. Check 163. Check 164. Check 165. Check 166. Check 167. Check 168. Check 169. Check 170. Check 171. Check 172. Check 173. Check 174. Check 175. Check 176. Check 177. Check 178. Check 179. Check 180. Check 181. Check 182. Check 183. Check 184. Check 185. Check 186. Check 187. Check 188. Check 189. Check 190. Check 191. Check 192. Check 193. Check 194. Check 195. Check 196. Check 197. Check 198. Check 199. Check 200. Check 201. Check 202. Check 203. Check 204. Check 205. Check 206. Check 207. Check 208. Check 209. Check 210. Check 211. Check 212. Check 213. Check 214. Check 215. Check 216. Check 217. Check 218. Check 219. Check 220. Check 221. Check 222. Check 223. Check 224. Check 225. Check 226. Check 227. Check 228. Check 229. Check 230. Check 231. Check 232. Check 233. Check 234. Check 235. Check 236. Check 237. Check 238. Check 239. Check 240. Check 241. Check 242. Check 243. Check 244. Check 245. Check 246. Check 247. Check 248. Check 249. Check 250. Check 251. Check 252. Check 253. Check 254. Check 255. Check 256. Check 257. Check 258. Check 259. Check 260. Check 261. Check 262. Check 263. Check 264. Check 265. Check 266. Check 267. Check 268. Check 269. Check 270. Check 271. Check 272. Check 273. Check 274. Check 275. Check 276. Check 277. Check 278. Check 279. Check 280. Check 281. Check 282. Check 283. Check 284. Check 285. Check 286. Check 287. Check 288. Check 289. Check 290. Check 291. Check 292. Check 293. Check 294. Check 295. Check 296. Check 297. Check 298. Check 299. Check 300. Check 301. Check 302. Check 303. Check 304. Check 305. Check 306. Check 307. Check 308. Check 309. Check 310. Check 311. Check 312. Check 313. Check 314. Check 315. Check 316. Check 317. Check 318. Check 319. Check 320. Check 321. Check 322. Check 323. Check 324. Check 325. Check 326. Check 327. Check 328. Check 329. Check 330. Check 331. Check 332. Check 333. Check 334. Check 335. Check 336. Check 337. Check 338. Check 339. Check 340. Check 341. Check 342. Check 343. Check 344. Check 345. Check 346. Check 347. Check 348. Check 349. Check 350. Check 351. Check 352. Check 353. Check 354. Check 355. Check 356. Check 357. Check 358. Check 359. Check 360. Check 361. Check 362. Check 363. Check 364. Check 365. Check 366. Check 367. Check 368. Check 369. Check 370. Check 371. Check 372. Check 373. Check 374. Check 375. Check 376. Check 377. Check 378. Check 379. Check 380. Check 381. Check 382. Check 383. Check 384. Check 385. Check 386. Check 387. Check 388. Check 389. Check 390. Check 391. Check 392. Check 393. Check 394. Check 395. Check 396. Check 397. Check 398. Check 399. Check 400. Check 401. Check 402. Check 403. Check 404. Check 405. Check 406. Check 407. Check 408. Check 409. Check 410. Check 411. Check 412. Check 413. Check 414. Check 415. Check 416. Check 417. Check 418. Check 419. Check 420. Check 421. Check 422. Check 423. Check 424. Check 425. Check 426. Check 427. Check 428. Check 429. Check 430. Check 431. Check 432. Check 433. Check 434. Check 435. Check 436. Check 437. Check 438. Check 439. Check 440. Check 441. Check 442. Check 443. Check 444. Check 445. Check 446. Check 447. Check 448. Check 449. Check 450. Check 451. Check 452. Check 453. Check 454. Check 455. Check 456. Check 457. Check 458. Check 459. Check 460. Check 461. Check 462. Check 463. Check 464. Check 465. Check 466. Check 467. Check 468. Check 469. Check 470. Check 471. Check 472. Check 473. Check 474. Check 475. Check 476. Check 477. Check 478. Check 479. Check 480. Check 481. Check 482. Check 483. Check 484. Check 485. Check 486. Check 487. Check 488. Check 489. Check 490. Check 491. Check 492. Check 493. Check 494. Check 495. Check 496. Check 497. Check 498. Check 499. Check 500. Check 501. Check 502. Check 503. Check 504. Check 505. Check 506. Check 507. Check 508. Check 509. Check 510. Check 511. Check 512. Check 513. Check 514. Check 515. Check 516. Check 517. Check 518. Check 519. Check 520. Check 521. Check 522. Check 523. Check 524. Check 525. Check 526. Check 527. Check 528. Check 529. Check 530. Check 531. Check 532. Check 533. Check 534. Check 535. Check 536. Check 537. Check 538. Check 539. Check 540. Check 541. Check 542. Check 543. Check 544. Check 545. Check 546. Check 547. Check 548. Check 549. Check 550. Check 551. Check 552. Check 553. Check 554. Check 555. Check 556. Check 557. Check 558. Check 559. Check 560. Check 561. Check 562. Check 563. Check 564. Check 565. Check 566. Check 567. Check 568. Check 569. Check 570. Check 571. Check 572. Check 573. Check 574. Check 575. Check 576. Check 577. Check 578. Check 579. Check 580. Check 581. Check 582. Check 583. Check 584. Check 585. Check 586. Check 587. Check 588. Check 589. Check 590. Check 591. Check 592. Check 593. Check 594. Check 595. Check 596. Check 597. Check 598. Check 599. Check 600. Check 601. Check 602. Check 603. Check 604. Check 605. Check 606. Check 607. Check 608. Check 609. Check 610. Check 611. Check 612. Check 613. Check 614. Check 615. Check 616. Check 617. Check 618. Check 619. Check 620. Check 621. Check 622. Check 623. Check 624. Check 625. Check 626. Check 627. Check 628. Check 629. Check 630. Check 631. Check 632. Check 633. Check 634. Check 635. Check 636. Check 637. Check 638. Check 639. Check 640. Check 641. Check 642. Check 643. Check 644. Check 645. Check 646. Check 647. Check 648. Check 649. Check 650. Check 651. Check 652. Check 653. Check 654. Check 655. Check 656. Check 657. Check 658. Check 659. Check 660. Check 661. Check 662. Check 663. Check 664. Check 665. Check 666. Check 667. Check 668. Check 669. Check 670. Check 671. Check 672. Check 673. Check 674. Check 675. Check 676. Check 677. Check 678. Check 679. Check 680. Check 681. Check 682. Check 683. Check 684. Check 685. Check 686. Check 687. Check 688. Check 689. Check 690. Check 691. Check 692. Check 693. Check 694. Check 695. Check 696. Check 697. Check 698. Check 699. Check 700. Check 701. Check 702. Check 703. Check 704. Check 705. Check 706. Check 707. Check 708. Check 709. Check 710. Check 711. Check 712. Check 713. Check 714. Check 715. Check 716. Check 717. Check 718. Check 719. Check 720. Check 721. Check 722. Check 723. Check 724. Check 725. Check 726. Check 727. Check 728. Check 729. Check 730. Check 731. Check 732. Check 733. Check 734. Check 735. Check 736. Check 737. Check 738. Check 739. Check 740. Check 741. Check 742. Check 743. Check 744. Check 745. Check 746. Check 747. Check 748. Check 749. Check 750. Check 751. Check 752. Check 753. Check 754. Check 755. Check 756. Check 757. Check 758. Check 759. Check 760. Check 761. Check 762. Check 763. Check 764. Check 765. Check 766. Check 767. Check 768. Check 769. Check 770. Check 771. Check 772. Check 773. Check 774. Check 775. Check 776. Check 777. Check 778. Check 779. Check 780. Check 781. Check 782. Check 783. Check 784. Check 785. Check 786. Check 787. Check 788. Check 789. Check 790. Check 791. Check 792. Check 793. Check 794. Check 795. Check 796. Check 797. Check 798. Check 799. Check 800. Check 801. Check 802. Check 803. Check 804. Check 805. Check 806. Check 807. Check 808. Check 809. Check 810. Check 811. Check 812. Check 813. Check 814. Check 815. Check 816. Check 817. Check 818. Check 819. Check 820. Check 821. Check 822. Check 823. Check 824. Check 825. Check 826. Check 827. Check 828. Check 829. Check 830. Check 831. Check 832. Check 833. Check 834. Check 835. Check 836. Check 837. Check 838. Check 839. Check 840. Check 841. Check 842. Check 843. Check 844. Check 845. Check 846. Check 847. Check 848. Check 849. Check 850. Check 851. Check 852. Check 853. Check 854. Check 855. Check 856. Check 857. Check 858. Check 859. Check 860. Check 861. Check 862. Check 863. Check 864. Check 865. Check 866. Check 867. Check 868. Check 869. Check 870. Check 871. Check 872. Check 873. Check 874. Check 875. Check 876. Check 877. Check 878. Check 879. Check 880. Check 881. Check 882. Check 883. Check 884. Check 885. Check 886. Check 887. Check 888. Check 889. Check 890. Check 891. Check 892. Check 893. Check 894. Check 895. Check 896. Check 897. Check 898. Check 899. Check 900. Check 901. Check 902. Check 903. Check 904. Check 905. Check 906. Check 907. Check 908. Check 909. Check 910. Check 911. Check 912. Check 913. Check 914. Check 915. Check 916. Check 917. Check 918. Check 919. Check 920. Check 921. Check 922. Check 923. Check 924. Check 925. Check 926. Check 927. Check 928. Check 929. Check 930. Check 931. Check 932. Check 933. Check 934. Check 935. Check 936. Check 937. Check 938. Check 939. Check 940. Check 941. Check 942. Check 943. Check 944. Check 945. Check 946. Check 947. Check 948. Check 949. Check 950. Check 951. Check 952. Check 953. Check 954. Check 955. Check 956. Check 957. Check 958. Check 959. Check 960. Check 961. Check 962. Check 963. Check 964. Check 965. Check 966. Check 967. Check 968. Check 969. Check 970. Check 971. Check 972. Check 973. Check 974. Check 975. Check 976. Check 977. Check 978. Check 979. Check 980. Check 981. Check 982. Check 983. Check 984. Check 985. Check 986. Check 987. Check 988. Check 989. Check 990. Check 991. Check 992. Check 993. Check 994. Check 995. Check 996. Check 997. Check 998. Check 999. Check 1000.